


ONE NEW CHANGE

ONE NEW CHANGE

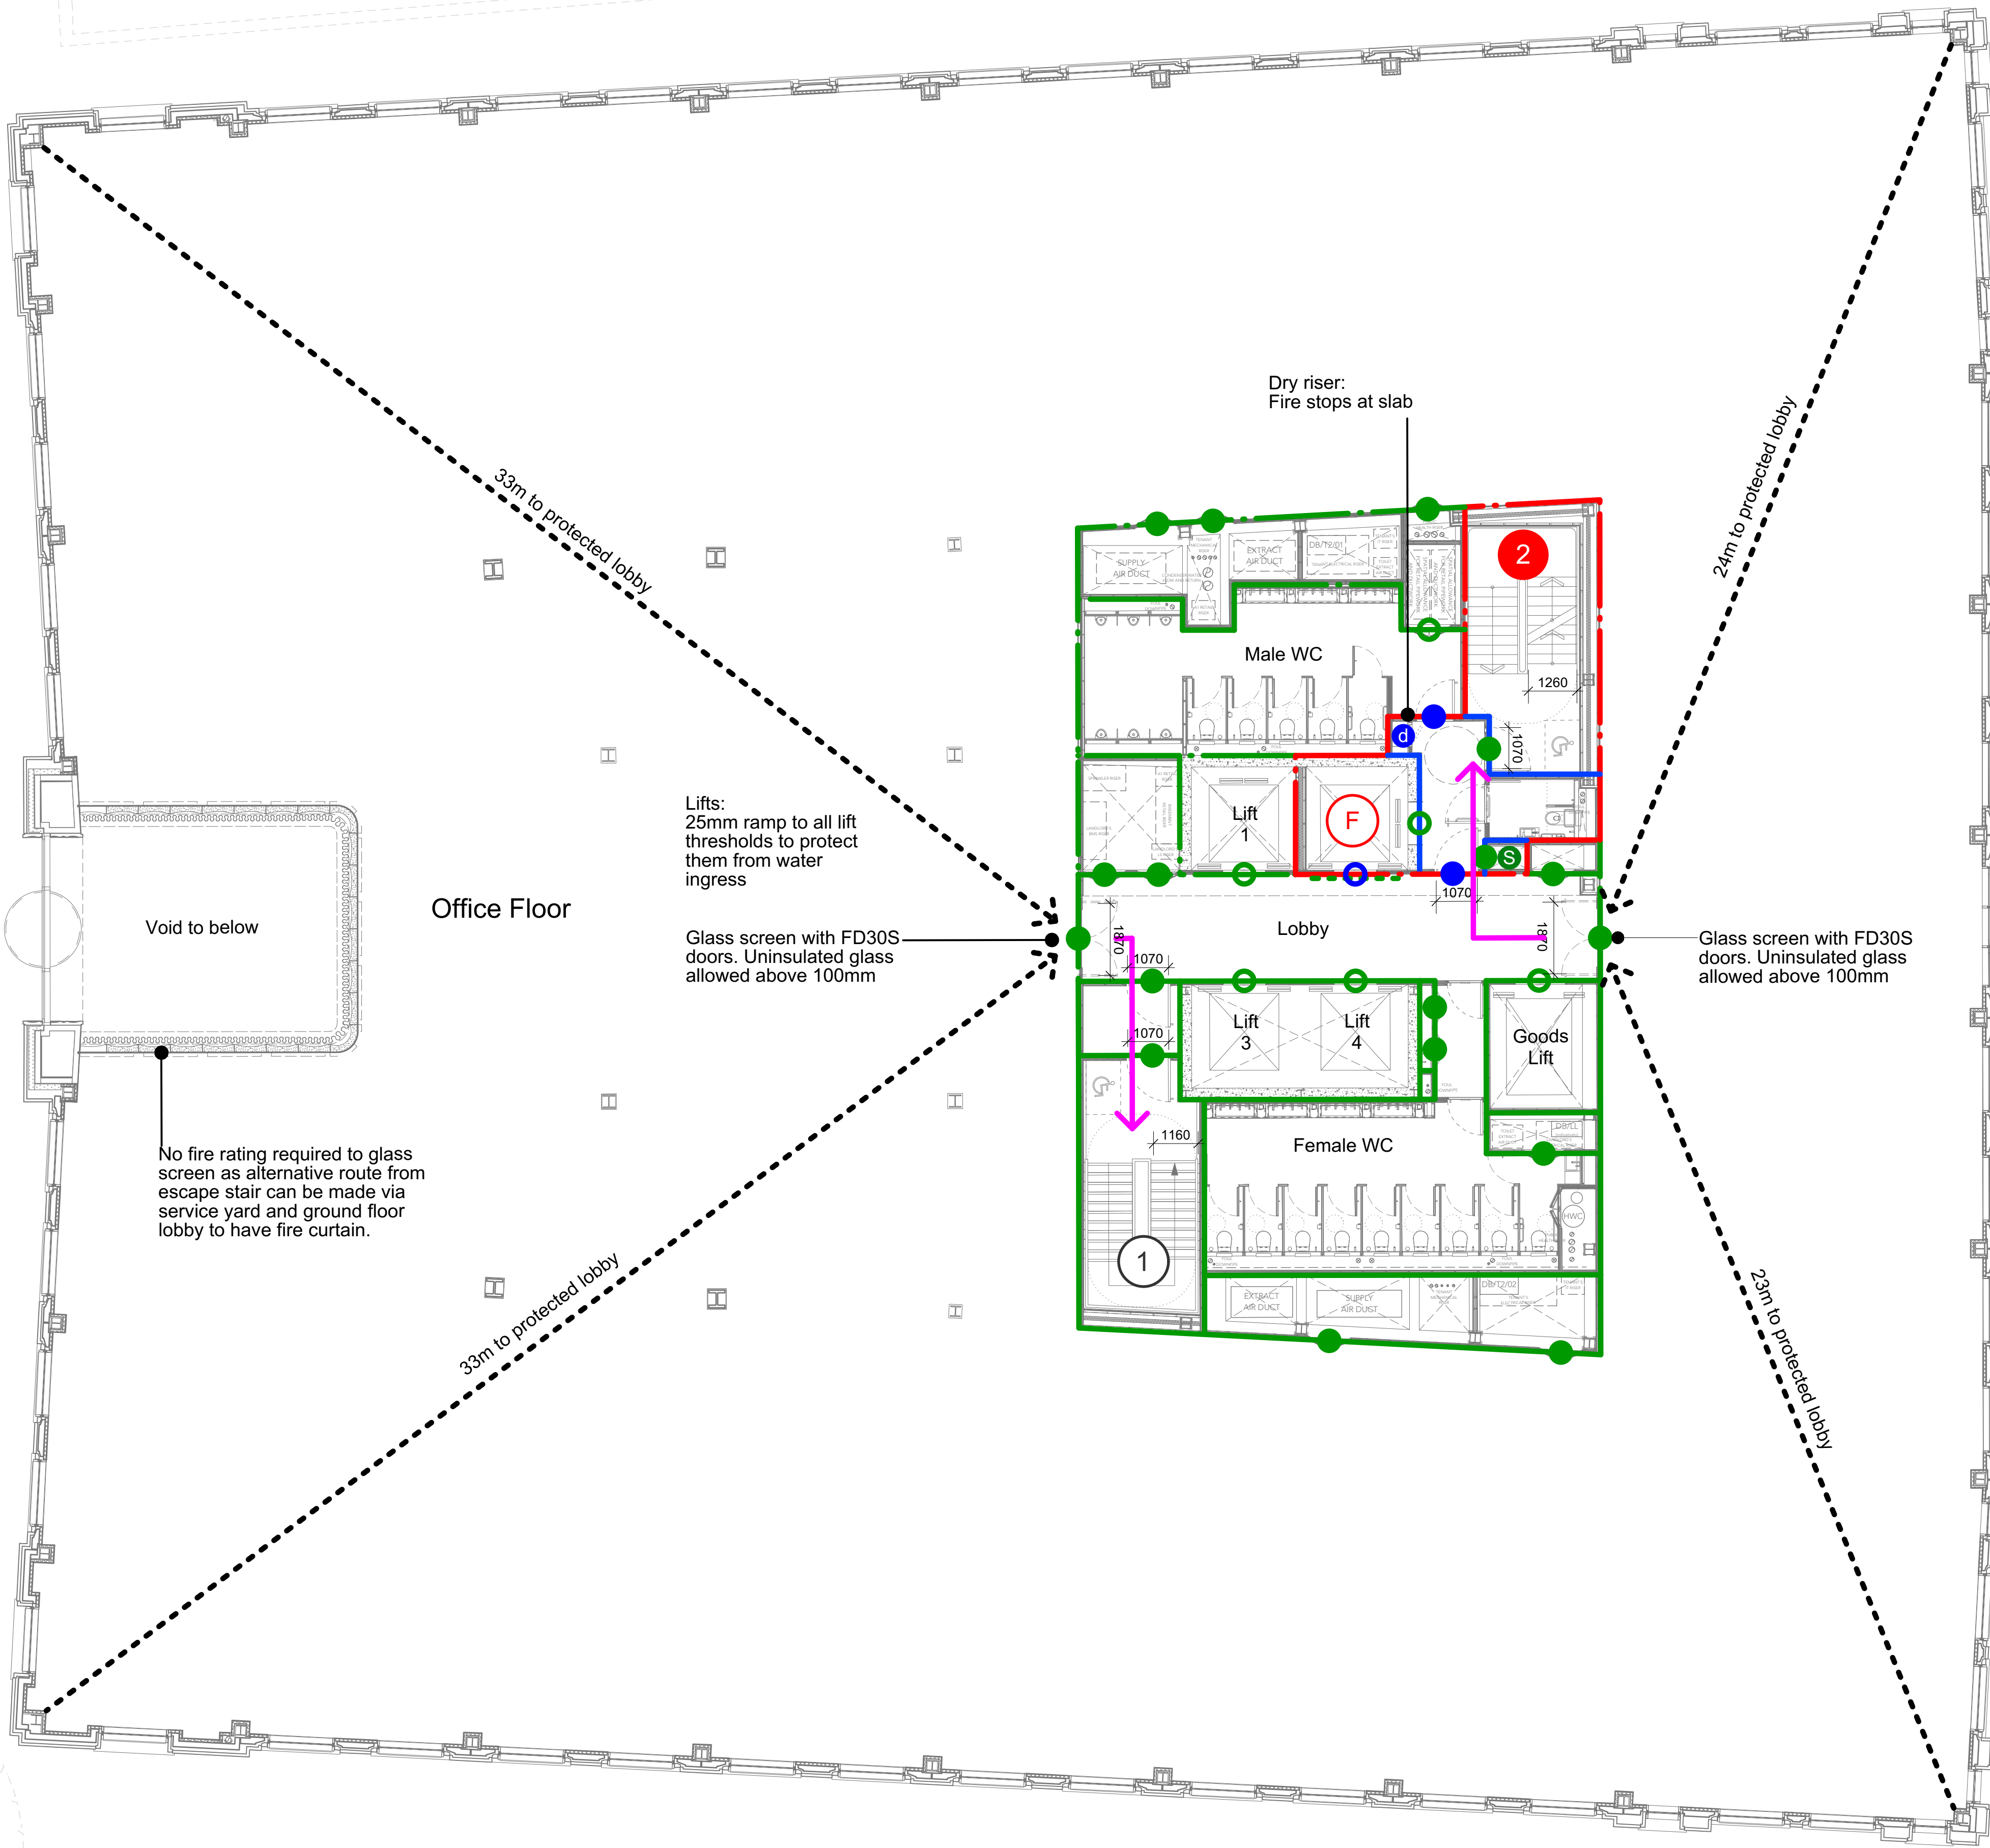

1 Proposed Fire Strategy - First Floor Plan
Scale: 1:100

DRAWING NOTES:
All dimensions to be checked on site prior to commencement of any works, and/or preparation of any shop drawings.
Sizes of and dimensions to any structural elements are indicative only. See structural engineers drawings for actual sizes/dimensions.
Sizes of and dimensions to any service elements are indicative only. See service engineers drawings for actual sizes and dimensions.
This drawing to be read in conjunction with all other Architect's drawings, specifications and other Consultants' information.
All proprietary systems shown on this drawing are to be installed strictly in accordance with the Manufacturers/Suppliers recommended details.
Any discrepancies between information shown on this drawing and any other contract information or manufacturers/suppliers recommendations is to be brought to the attention of the Architect.
DO NOT SCALE FROM THIS DRAWING.

DRAWING NOTES:	① FIRE-FIGHTING LIFT
	② STAIR 1
	③ STAIR 2 (FIRE-FIGHTING)
	④ STAIR 3, 5TH FLOOR TO ROOF
	⑤ SMOKE EXTRACT SHAFT & AOV
	⑥ FIRE / SMOKE CURTAIN (FR 30 MIN. WITH SMOKE SEALS)
	⑦ FINAL EXIT, GROUND FLOOR

⑧ 120 MIN (OUT>IN) / 60 MIN (IN>OUT) INTEGRITY & INSULATION
⑨ 60 MINUTES INTEGRITY AND INSULATION
⑩ 30 MINUTES INTEGRITY AND INSULATION
⑪ MAINTAIN EXISTING UKPN FIRE ENCLOSURE RATING
⑫ DRY RISER OUTLET
⑬ DRY RISER CONNECTION POINT

⑭ ESCAPE ROUTES
⑮ ESCAPE DISTANCES
⑯ ESCAPE ROUTE FOR OFFICE USERS
⑰ ESCAPE ROUTE FOR MAINTENANCE OPERATIVES
⑱ SEE BG01 RC_SERIES & MTT LIGHTING PLANS FOR ILLUMINATED FIRE EXIT SIGNS
⑲ ESCAPE ROUTES - ROOF
⑳ ILLUMINATED RUNNING MAN FIRE EXIT SIGNS

① FD 120S DOOR
② FD 120 DOOR
③ FD 60S DOOR
④ FD 60 DOOR
⑤ FD 30S DOOR
⑥ FD 30 DOOR

C1	FIRST CONSTRUCTION ISSUE.	16/01/20
T1	ESCAPE ROUTES ADDED.	05/06/19
	STAGE 4 ISSUE	
STATUS	REVISION	DATE

DRAWING	Fire Strategy
SCALE	1:100 @ A0
DATE	May 2019
DWG No.	1069_FS-01
DRAWING STATUS	CONSTRUCTION
REVISION	C1
CLIENT	25 Cannon Street Limited
PROJECT	25 Cannon Street, EC4M

Buckley Gray Yeoman
Studio 4.04 The Tea Building 55 Shoreditch High Street London E1 6JJ T: 020 7033 9913 F: 020 7033 9914
25 Cannon Street Limited
25 Cannon Street, EC4M