


ONE NEW CHANGE

ONE NEW CHANGE

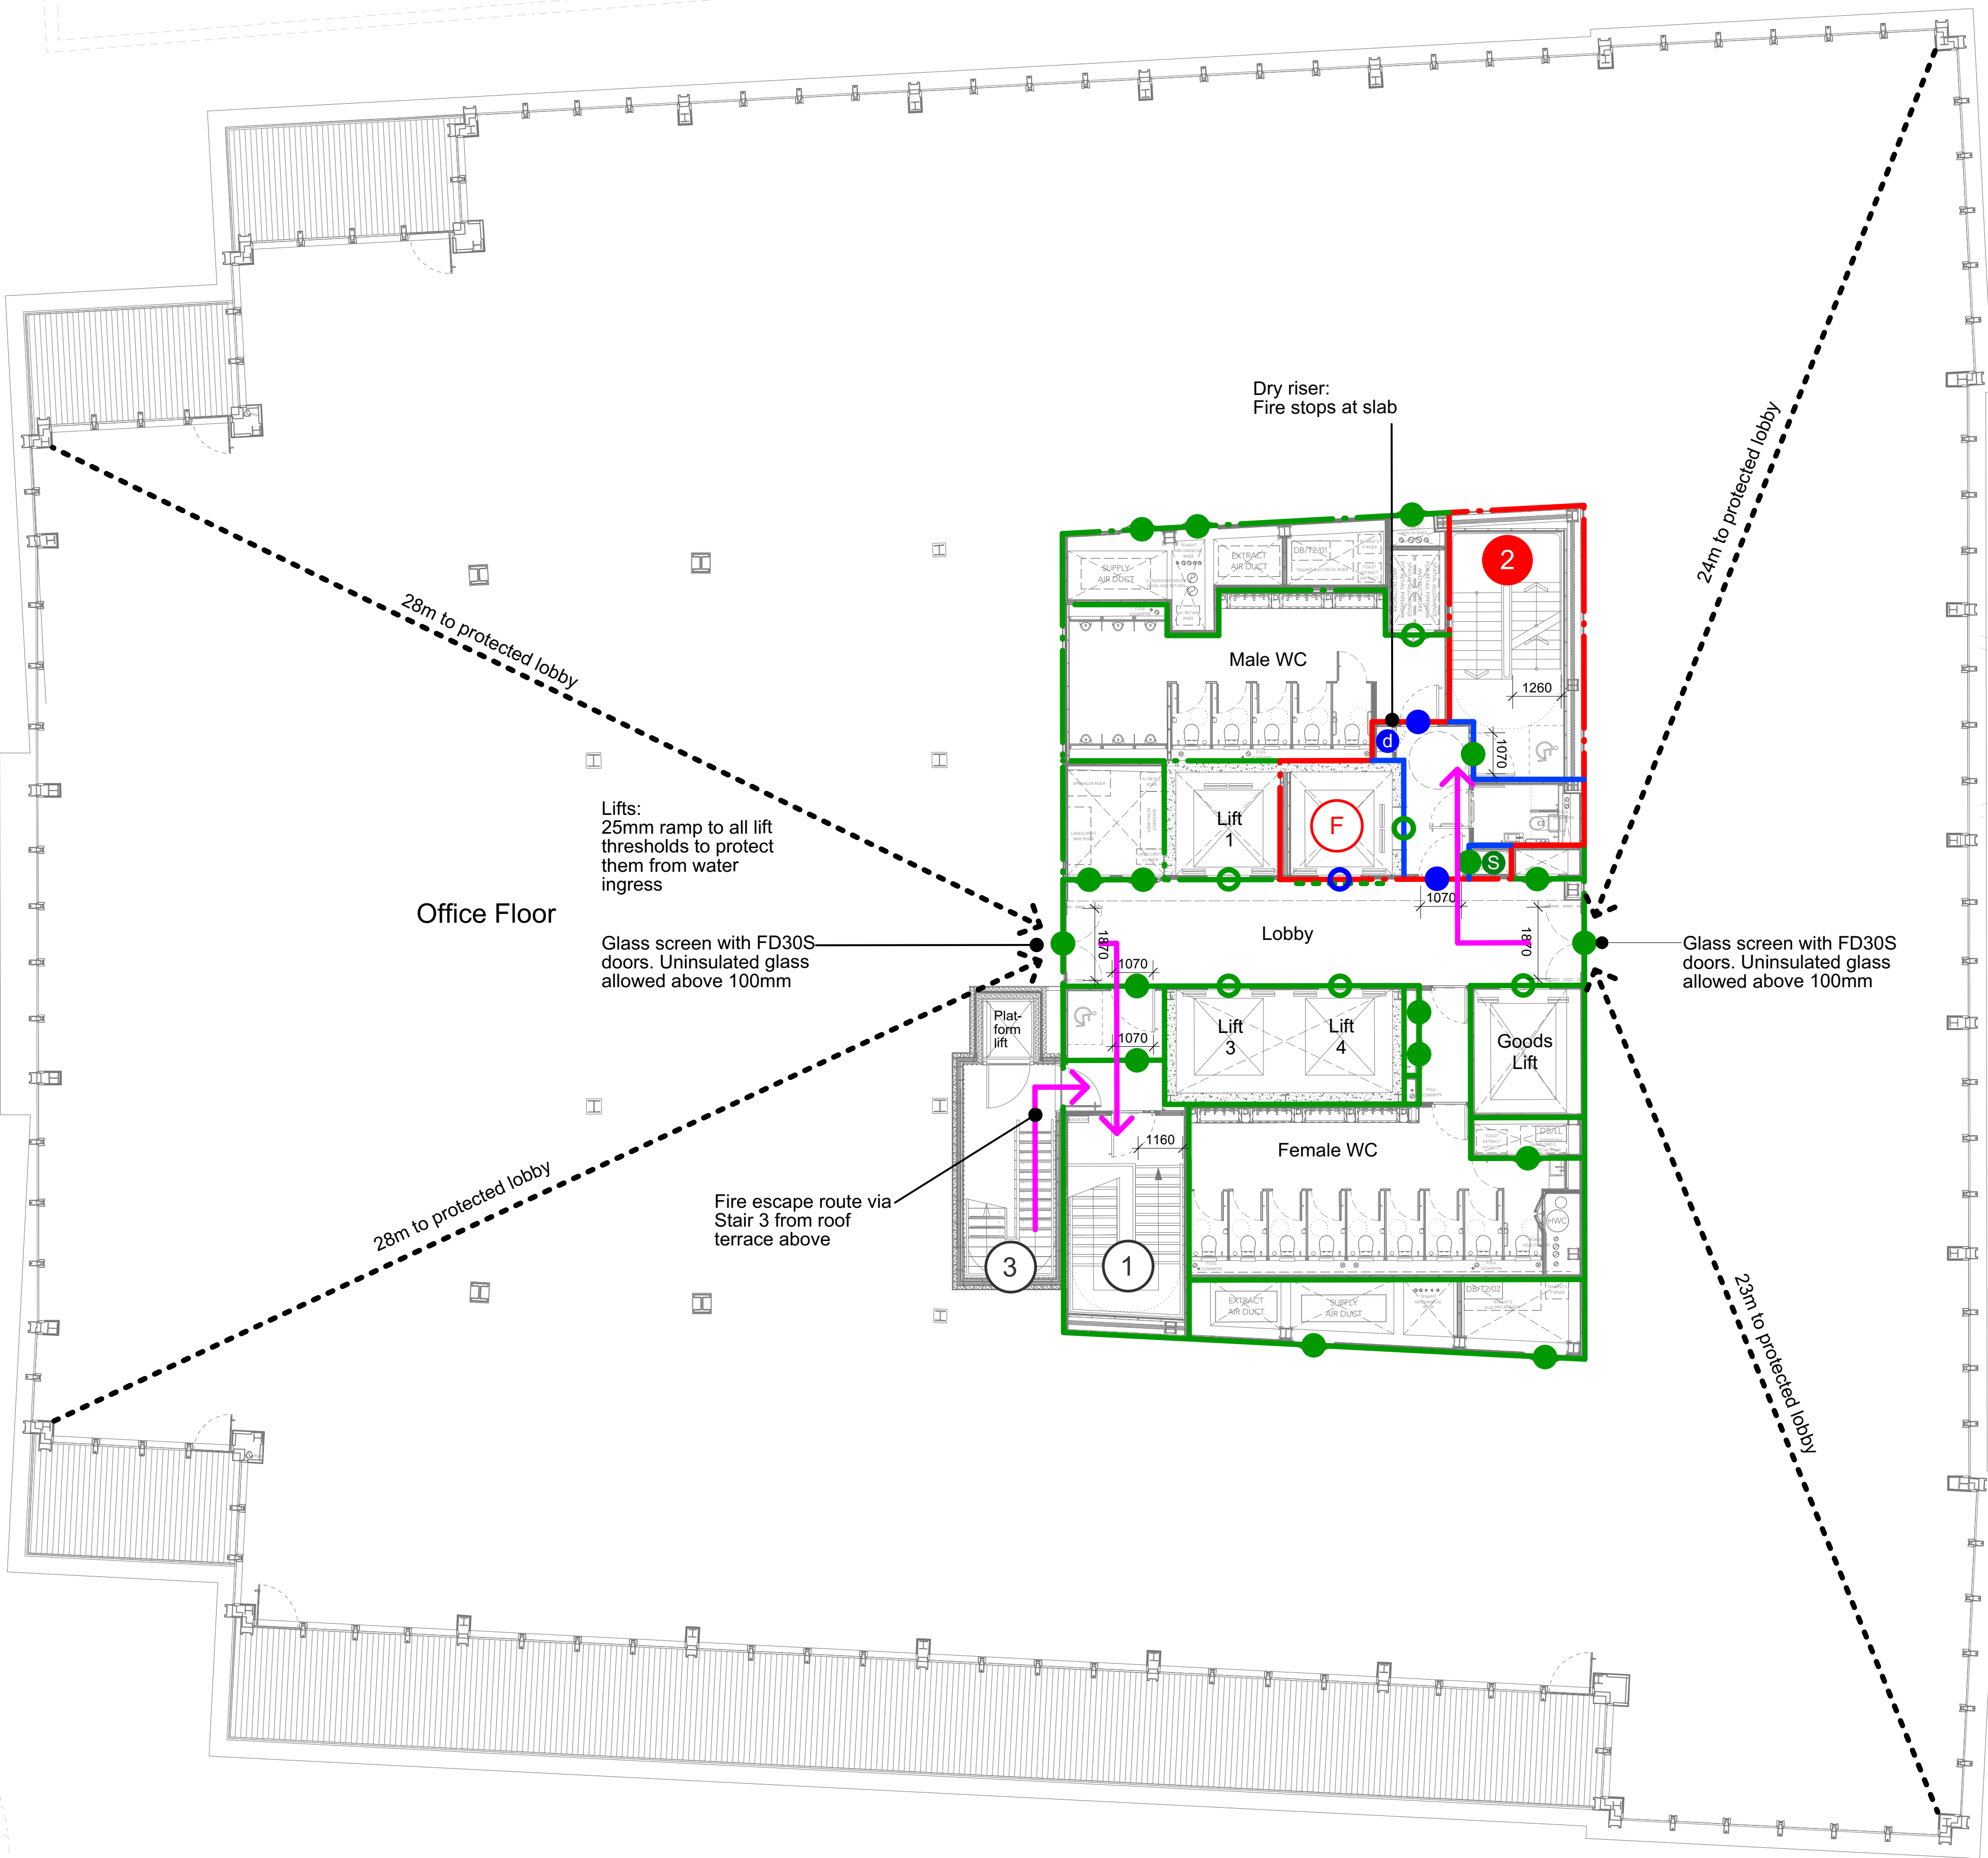

1 Proposed Fire Strategy - Fifth Floor Plan
Scale: 1:100

DRAWING NOTES:
All dimensions to be checked on site prior to commencement of any works, and/or preparation of any shop drawings.
Sizes of and dimensions to any structural elements are indicative only. See structural engineers drawings for actual sizes and dimensions.
Sizes of and dimensions to any service elements are indicative only. See service engineers drawings for actual sizes and dimensions.
This drawing is to be read in conjunction with all other Architect's drawings, specifications and other Consultants' information.
All proprietary systems shown on this drawing are to be installed strictly in accordance with the Manufacturers/Suppliers recommended details.
Any discrepancies between information shown on this drawing and any other contract information or manufacturers/suppliers recommendations is to be brought to the attention of the Architect.
DO NOT SCALE FROM THIS DRAWING.

DRAWING NOTES:	
	FIRE-FIGHTING LIFT
	STAIR 1
	STAIR 2 (FIRE-FIGHTING)
	STAIR 3, 5TH FLOOR TO ROOF
	SMOKE EXTRACT SHAFT & AOV
	FIRE / SMOKE CURTAIN (FR 30 MIN. WITH SMOKE SEALS)
	FINAL EXIT, GROUND FLOOR

	120 MIN (OUT>IN) / 60 MIN (IN>OUT) INTEGRITY & INSULATION
	60 MINUTES INTEGRITY AND INSULATION
	30 MINUTES INTEGRITY AND INSULATION
	MAINTAIN EXISTING UKPN FIRE ENCLOSURE RATING
	DRY RISER OUTLET
	DRY RISER CONNECTION POINT

ESCAPE ROUTES	
	ESCAPE DISTANCES
	ESCAPE ROUTE FOR OFFICE USERS
	ESCAPE ROUTE FOR MAINTENANCE OPERATIVES
SEE BGY RC_SERIES & MTT LIGHTING PLANS FOR ILLUMINATED FIRE EXIT SIGNS	
ESCAPE ROUTES - ROOF	
	ILLUMINATED RUNNING MARY FIRE EXIT SIGNS
	EXIT

	FD 120S DOOR
	FD 120 DOOR
	FD 60S DOOR
	FD 60 DOOR
	FD 30S DOOR
	FD 30 DOOR

C1	FIRST CONSTRUCTION ISSUE
T1	ESCAPE ROUTES ADDED. STAGE 4 ISSUE
STATUS	REVISION

16/01/20	05/06/19
DATE	

DRAWING	Fire Strategy Proposed Fifth Floor Plan
SCALE	1:100 @ A0
DATE	May 2019
DWG No.	1069_FS-05
DRAWING STATUS	CONSTRUCTION
REVISION	C1

Buckley Gray Yeoman	Studio 4.04 The Tea Building 55 Shoreditch High Street London E1 6JJ T: 020 7033 9913 F: 020 7033 9914
CLIENT	25 Cannon Street Limited
PROJECT	25 Cannon Street, EC4M